




ARCHITECTS
ORANGE
144 North Orange Street • Orange, California 92665 • 714.639.9800



**SADDLEBACK
GIBSON
BUSINESS PARK
HENDERSON, NV**

Saddleback Associates
30398 Esperanza
Rancho Santa Margarita
California 92688
949.635.1970

**SITE PLAN
LUNCH CANOPIES**

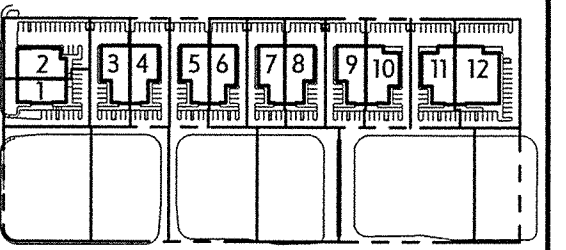

KEY PLAN


© 2004 Architects Orange
These plans are copyright controlled documents.
Each presentation, reproduction, use in any medium,
These plans shall not be reproduced or used
without written permission by Architects Orange.

DATE


Plan Check	
Blk Set	
Permit	
Project Number	A4001
Drawing Name	4001SP
Plot Date	11-05-04
	PLAN CHECK

SHEET

A1.1

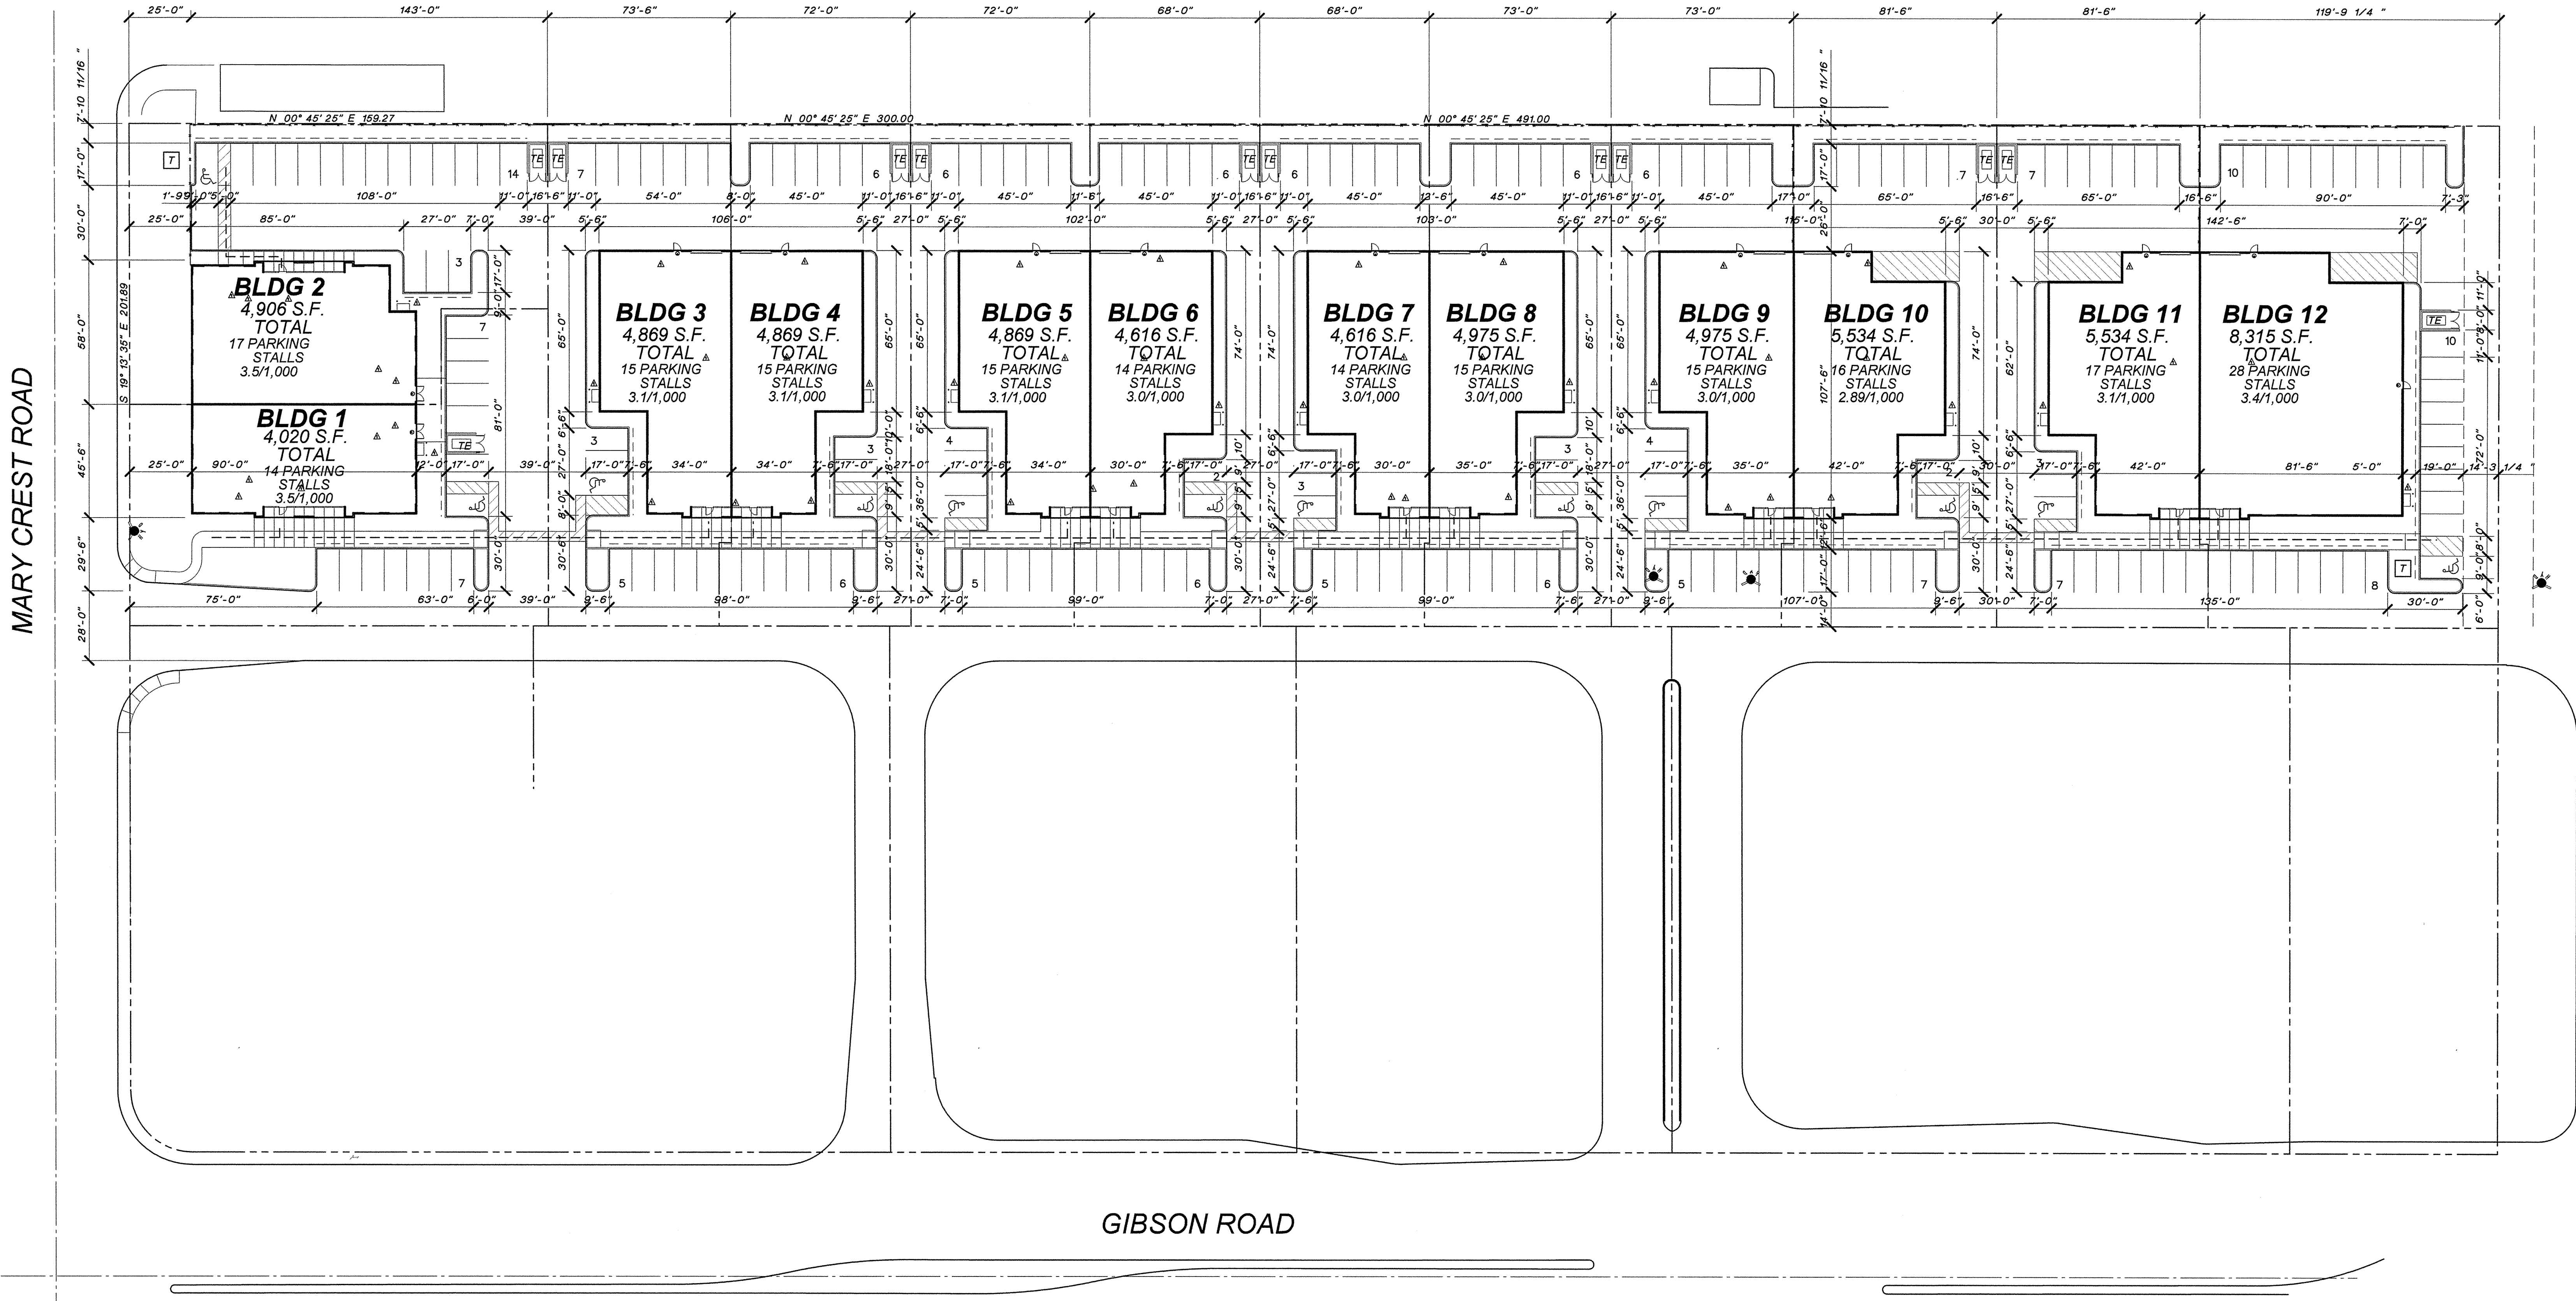

SITE PLAN

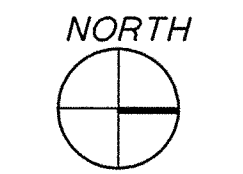

SITE PLAN

1"=30'-0" **4**

- | | |
|---|--|
| <ul style="list-style-type: none"> 13 TRASH ENCLOSURE SEE (12) A1.2 14 ELECTRICAL TRANSFORMER 15 WATER METER LOCATION PER CIVIL DRAWINGS 16 ELECTRICAL PANEL - SEE ELECTRICAL DWGS 17 SIDEWALK CURB RAMP 18 MEDIUM BROOM FINISH WALK W/ CONTROL JOINTS AT 4'-0" O.C. 19 CROSSWALK. SEE DETAIL 9/A2 20 FIRE LANE CURB STRIPING SEE (28) A1.2 21 12'-0" x 35'-0" LOADING ZONE. 4" WIDE YELLOW STRIPED BORDER W/ 4" WIDE YELLOW FIELD STRIPES AT 45 DEGREES | <ul style="list-style-type: none"> 1 ASPHALT PAVING. SEE CIVIL DRAWINGS FOR SECTIONS AND ADDITIONAL INFORMATION 2 TRAFFIC ENTRY WARNING SIGN. SEE (17) A1.2 3 TYPICAL PARKING STALL STRIPING. WHITE HIGHWAY PAINT 4" WIDE, SEE DETAIL 1/A1.2 4 CONCRETE CURB OR CURB AND GUTTER PER CIVIL DRAWINGS. 5 LANDSCAPE AREA. SEE LANDSCAPE DRAWINGS FOR PLANTING AND IRRIGATION. 6 ACCESSIBLE PATH OF TRAVEL SHALL HAVE A SLOPE NOT TO EXCEED 5% AND A CROSS SLOPE NOT TO EXCEED 2% 7 GAS METER LOCATION, SEE PLUMBING PLANS 8 FIRE TRUCK TURNING RADIUS, 28'-0" INSIDE, 52'-0" OUTSIDE 9 PAINTED METAL FENCE SEE (7) A1.2 10 PROPERTY LINE - SEE CIVIL DRAWINGS 11 NEW PRIVATE FIRE HYDRANT LOCATION - SEE CIVIL 12 EXISTING PUBLIC FIRE HYDRANT |
|---|--|